

UPPER BLACKSTONE WATER POLLUTION ABATEMENT DISTRICT

WASTEWATER TREATMENT FACILITY IMPROVEMENTS PHASE II

CONTRACT NO. UB 3 - 0 - 17512 - 0023

PROJECT NO. CWSRF - 2880

BOARD OF DIRECTORS

ROBERT L. MOYLAN JR, CHAIRMAN
J. BRADFORD LANGE, VICE CHAIRMAN
MATTHEW J. LABOVITES, SECRETARY

ENGINEER DIRECTOR / TREASURER


THOMAS K. WALSH, P.E.

PLANT MANAGER

PAUL CARON

DISTRICT ENGINEER

KARLA SANGREY, P.E.

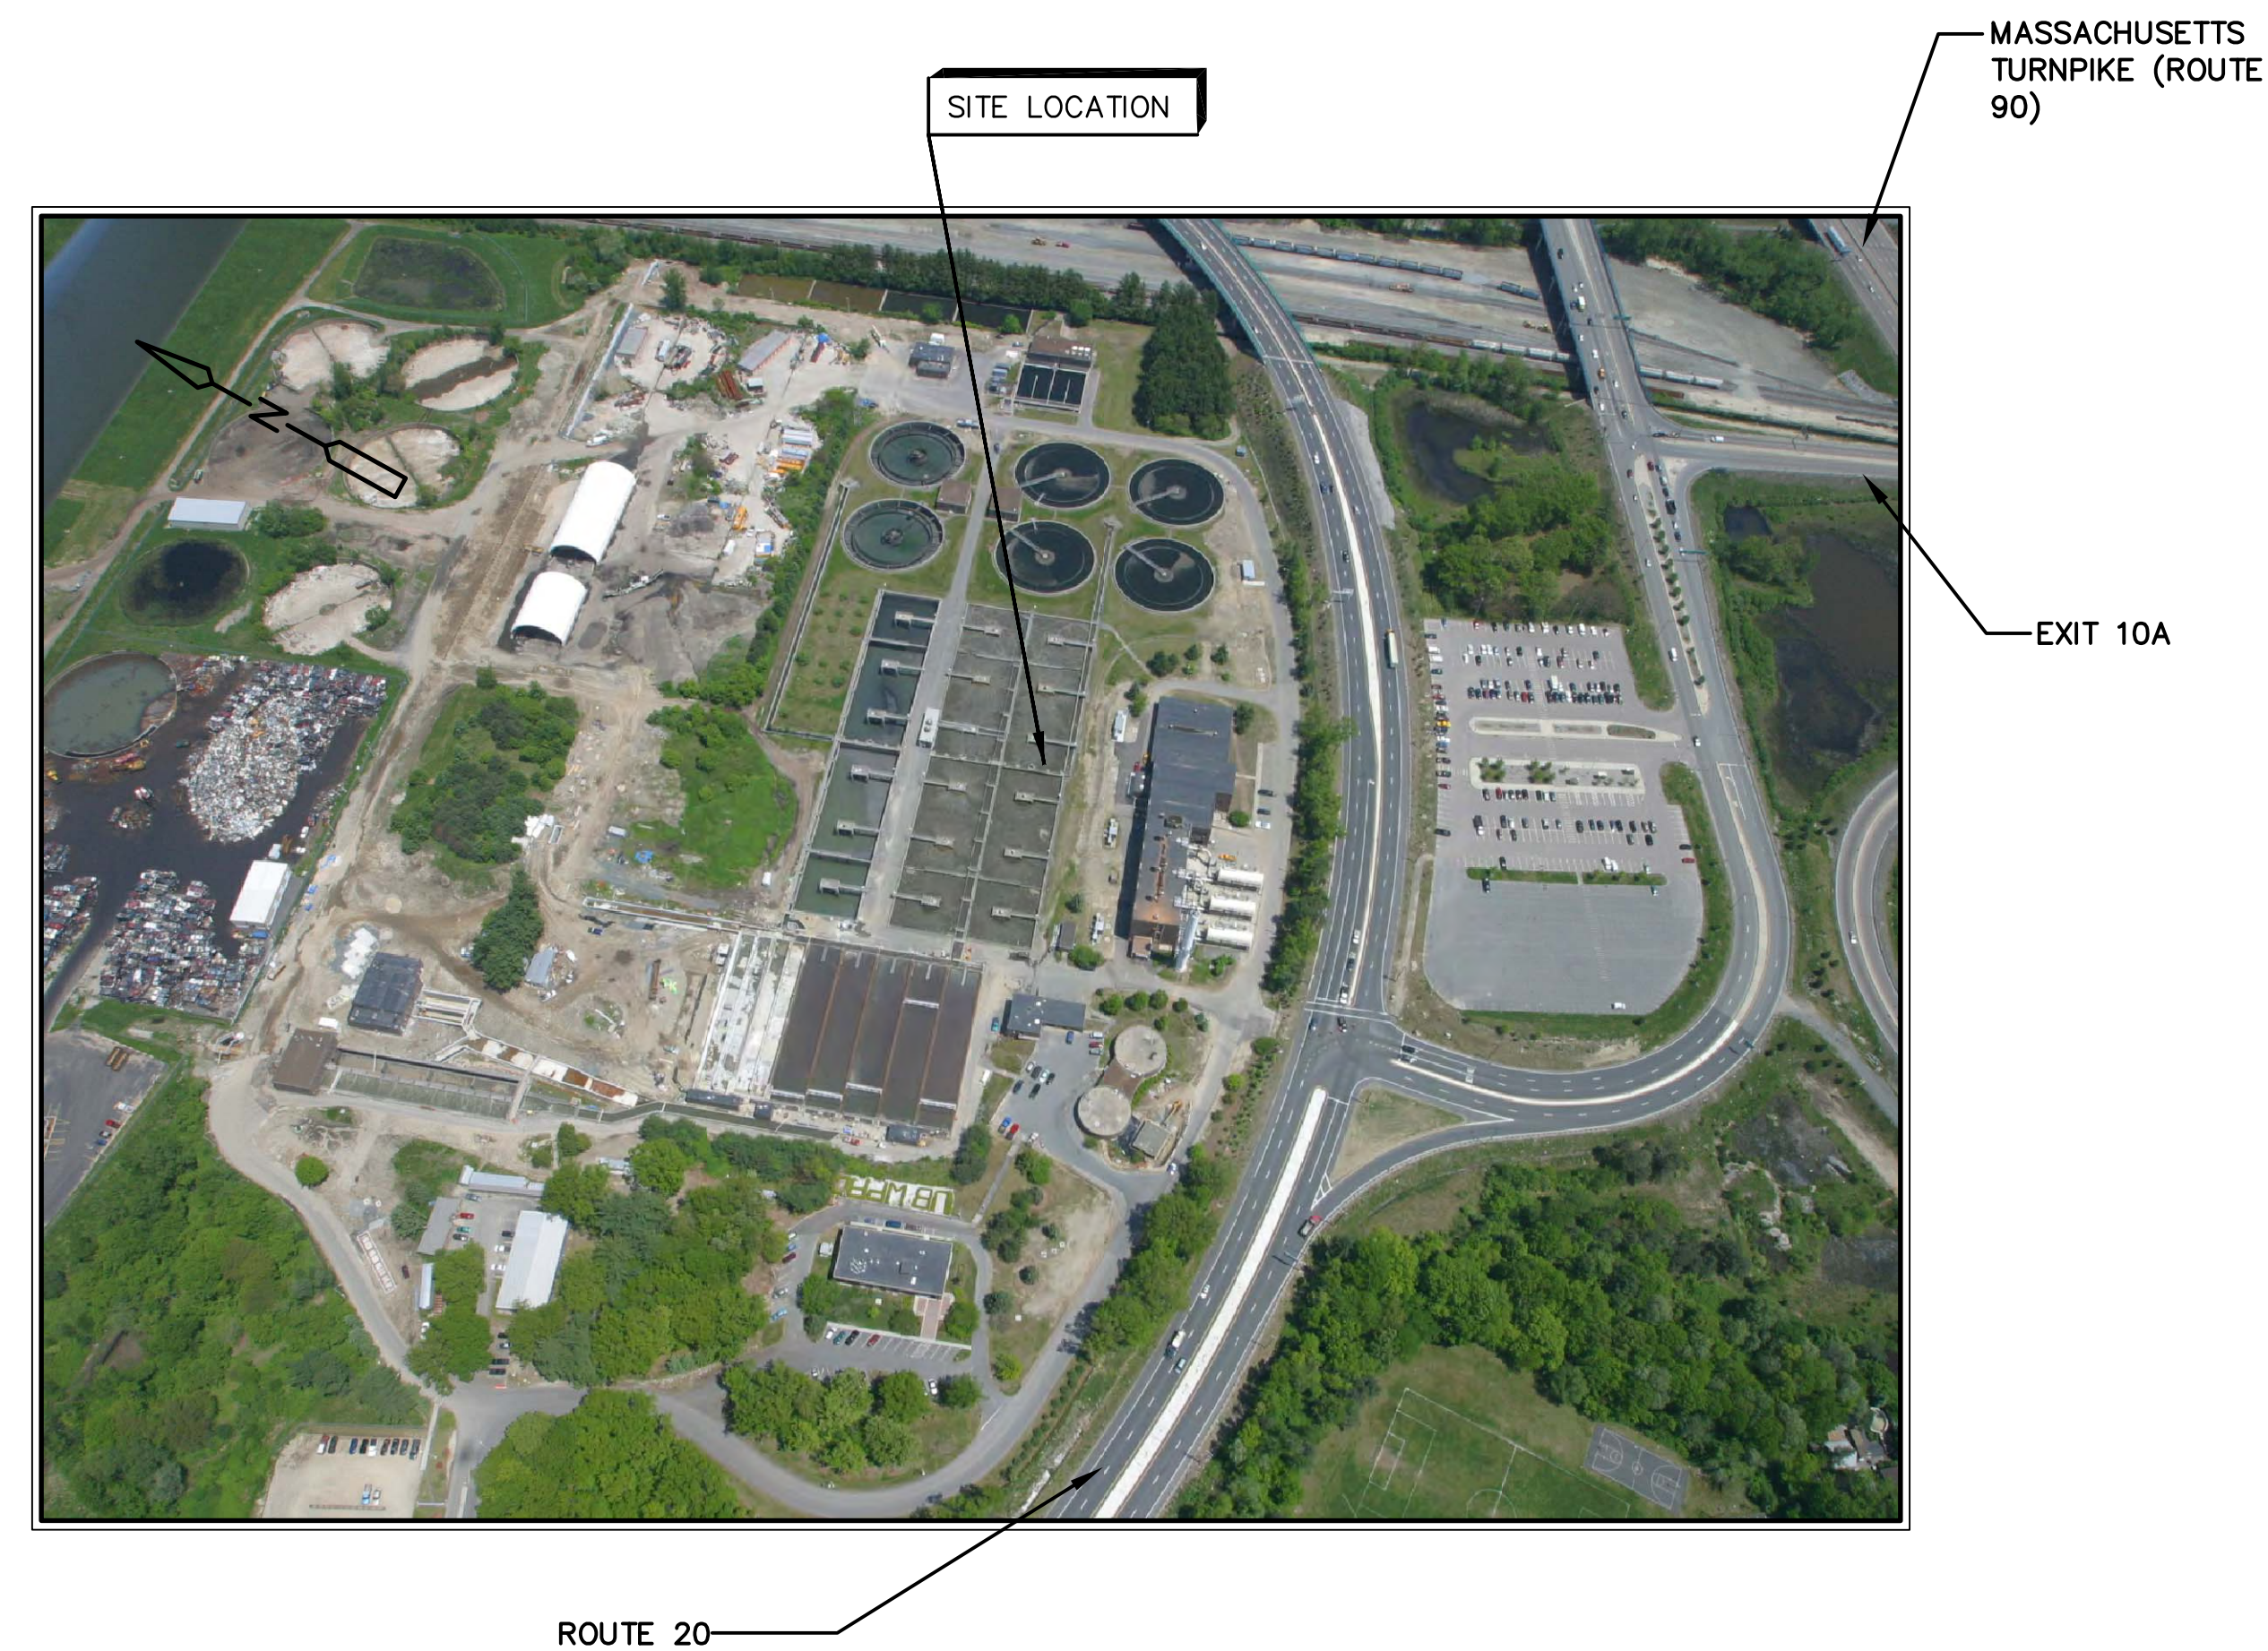

LOCATION PLAN

APPROXIMATE SCALE: 1"=250'

RECORD DRAWING
NOVEMBER 2009

UNOFFICIAL CONFORMED CONTRACT DRAWINGS ARE FOR USE BY THE UPPER BLACKSTONE WASTEWATER TREATMENT FACILITY CONSTRUCTION MANAGEMENT STAFF ONLY AND ARE PROVIDED SOLELY FOR INFORMATION.

CDM Camp Dresser & McKee Inc.
CAMBRIDGE, MASSACHUSETTS

Consulting

Engineering

Construction

INDEX SHEET

GENERAL

- 2 GD-1 INDEX OF DRAWINGS I
- 3 GD-2 INDEX OF DRAWINGS II
- 4 GD-3 DESIGN CRITERIA - PHASE II
- 5 GD-4 HYDRAULIC PROFILE - AT COMPLETION OF PHASE II
- 6 GD-5 LIQUID PROCESS FLOW DIAGRAM - PHASE II

CIVIL

- 7 C-1 CIVIL/SITE LEGEND, NOTES AND ABBREVIATIONS
- 8 C-2 OVERVIEW PLAN
- 9 C-3 BORING PLAN
- 10 C-4 EXISTING CONDITIONS AND SITE REMOVAL PLAN I
- 11 C-5 EXISTING CONDITIONS AND SITE REMOVAL PLAN II
- 12 C-6 EXISTING CONDITIONS AND SITE REMOVAL PLAN III
- 13 C-7 EXISTING CONDITIONS AND SITE REMOVAL PLAN IV
- 14 C-8 LAYOUT, GRADING AND EROSION CONTROL PLAN I
- 15 C-9 LAYOUT, GRADING AND EROSION CONTROL PLAN II
- 16 C-10 LAYOUT, GRADING AND EROSION CONTROL PLAN III
- 17 C-11 LAYOUT, GRADING AND EROSION CONTROL PLAN IV
- 18 C-12 ENLARGED LANDSCAPING PLAN I
- 19 C-13 AERATION CONTROL FACILITY - DEMOLITION-PLAN, SECTION AND DETAILS
- 20 C-14 OVERALL YARD PIPING PLAN
- 21 C-15 ENLARGED YARD PIPING PLAN I
- 22 C-16 ENLARGED YARD PIPING PLAN II
- 23 C-17 ENLARGED YARD PIPING PLAN III
- 24 C-18 ENLARGED YARD PIPING PLAN IV
- 25 C-19 AERATION TANKS UNDERDRAIN SYSTEM LAYOUT
- 26 C-20 ENLARGED PLAN AND SECTIONS
- 27 C-21 SEWAGE PUMP STATION
- 28 C-22 FINAL SETTLING TANK EFFLUENT PIPING PROFILE
- 29 C-23 SITE DETAILS I
- 30 C-24 SITE DETAILS II
- 31 C-25 CIVIL DETAILS I
- 32 C-26 CIVIL DETAILS II
- 33 C-27 ORIGINAL IMHOFF TANK DESIGN PLAN
- 34 C-28 ORIGINAL IMHOFF TANK DESIGN SECTION
- 35 C-29 ASH LANDFILL CLOSURE EXISTING CONDITIONS PLAN
- 36 C-30 ASH LANDFILL CLOSURE FINAL CONDITION PLAN
- 37 C-31 ASH LANDFILL CLOSURE TYPICAL PROFILES
- 38 C-32 ASH LANDFILL CLOSURE MISC DETAILS I
- 39 C-33 ASH LANDFILL CLOSURE MISC DETAILS II
- 40 SR-1 SITE REMEDIATION PLAN
- 41 SR-2 SITE REMEDIATION PLAN - IMHOFF TANKS - ENLARGED PLAN
- 42 SR-3 SITE REMEDIATION PLAN - IMHOFF TANKS - SECTION I
- 43 SR-4 SITE REMEDIATION PLAN - IMHOFF TANKS - SECTION II
- 44 SR-5 SITE REMEDIATION- PROPOSED CAPPING/DRAINAGE/GRADING PLAN
- 45 SR-6 SITE REMEDIATION- TWO-PHASE EXTRACTION SYSTEM PLANS AND DETAILS

ARCHITECTURAL

- 46 GD-A-1 ABBREVIATIONS AND LEGEND
- 47 GD-A-2 BUILDING CODE SUMMARY, FINISH SCHEDULE AND PARTITION TYPES
- 48 PS-A-1 SLUDGE RECIRCULATING PUMP STATIONS (SOUTH AND NORTH) - DEMOLITION - PLANS AND ELEVATIONS
- 49 PS-A-2 SLUDGE RECIRCULATING PUMP STATIONS (SOUTH AND NORTH) - NEW PLANS AND ELEVATIONS
- 50 SP-A-1 SLUDGE PROCESSING COMPLEX OPERATIONS - LOCKER/LUNCH FACILITIES - DEMOLITION AND NEW - PARTIAL FLOOR PLANS
- 51 SP-A-2 SLUDGE PROCESSING COMPLEX OPERATIONS - LOCKER/LUNCH FACILITIES - ELEVATIONS AND REFLECTED CEILING PLAN
- 52 SP-A-3 SLUDGE PROCESSING COMPLEX OPERATIONS - WALL SECTIONS AND PARTIAL NORTH ELEVATIONS
- 53 SP-A-4 SLUDGE PROCESSING COMPLEX OPERATIONS - WALL SECTIONS AND PARTIAL WEST ELEVATIONS
- 54 MB-A-1 MAINTENANCE BUILDING - DEMOLITION - FIRST FL, SECOND FL AND ROOF PLANS
- 55 MB-A-2 MAINTENANCE BUILDING - DEMOLITION - EXTERIOR ELEVATIONS AND DETAILS
- 56 MB-A-3 MAINTENANCE BUILDING - FIRST FL, SECOND FL, ROOF AND REFLECTED CEILING PLANS
- 57 MB-A-4 MAINTENANCE BUILDING - ELEVATIONS AND DETAILS
- 58 MB-A-5 MAINTENANCE SUPPORT FACILITY - FLOOR, ROOF, REFLECTED CEILING AND ENLARGED PLANS
- 59 MB-A-6 MAINTENANCE SUPPORT FACILITY - ELEVATIONS AND BUILDING SECTIONS
- 60 MB-A-7 MAINTENANCE SUPPORT FACILITY - WALL SECTIONS
- 61 MB-A-8 MAINTENANCE SUPPORT FACILITY AND SLUDGE PROCESSING BUILDING - INTERIOR ELEVATIONS
- 62 SD-A-1 ROOF DETAILS

ARCHITECTURAL CONTINUED

- 63 SD-A-2 PLAN AND MISCELLANEOUS DETAILS
- 64 SD-A-3 SCHEDULES, DOOR, WINDOW AND LOUVER TYPES
- 65 SD-A-4 DOOR, WINDOW AND LOUVER DETAILS I
- 66 SD-A-5 DOOR, WINDOW AND LOUVER DETAILS II
- 67 SD-A-6 DOOR, WINDOW AND LOUVER DETAILS III

STRUCTURAL

- 68 PT-S-1 PRIMARY SETTLING TANK CHANNEL - EPOXY LINING PLAN AND SECTIONS
- 69 AT-S-1 AERATION TANKS - DEMOLITION PLAN I
- 70 AT-S-2 AERATION TANKS - DEMOLITION PLAN II
- 71 AT-S-3 AERATION TANKS - BASE PLAN I
- 72 AT-S-4 AERATION TANKS - BASE PLAN II
- 73 AT-S-5 ADD ALTERNATE NO. 2 AERATION TANKS - BASE PLAN III
- 74 AT-S-6 AERATION TANKS - TOP PLAN I
- 75 AT-S-7 AERATION TANKS - TOP PLAN II
- 76 AT-S-8 ADD ALTERNATE NO. 2 AERATION TANKS - TOP PLAN III
- 77 AT-S-9 AERATION TANKS - ENLARGED PLANS I
- 78 AT-S-10 AERATION TANKS - CONCRETE SECTIONS & DETAILS I
- 79 AT-S-11 AERATION TANKS - CONCRETE SECTIONS & DETAILS II
- 80 AT-S-12 AERATION TANKS - CONCRETE SECTIONS & DETAILS III
- 81 AT-S-13 AERATION TANKS - CONCRETE SECTIONS & DETAILS IV
- 82 AT-S-14 AERATION TANKS - CONCRETE SECTIONS & DETAILS V
- 83 AT-S-15 AERATION TANKS - CONCRETE SECTIONS & DETAILS VI
- 84 AT-S-16 AERATION TANKS - CONCRETE SECTIONS & DETAILS VII
- 85 AT-S-17 AERATION TANKS - CONCRETE SECTIONS & DETAILS VIII
- 86 AT-S-18 ADD ALTERNATE NO. 2 AERATION TANKS - CONCRETE SECTIONS & DETAILS IX
- 87 AT-S-19 AERATION TANKS - ENLARGED PLANS II
- 88 AT-S-20 AERATION TANKS - ENLARGED PLANS III
- 89 AT-S-21 BLOWER, SUBSTATION & AIR PIPING - FOUNDATION PLAN
- 90 AT-S-22 BLOWER, SUBSTATION & AIR PIPING - SECTIONS & DETAILS
- 90A AT-S-24 EXISTING WET WEATHER DISCHARGE CHANNEL AND GATE STRUCTURE DEMOLITION PLAN, SECTIONS AND DETAILS
- 90B AT-S-25 EXISTING WET WEATHER DISCHARGE CHANNEL AND GATE STRUCTURE NEW WORK PLAN, SECTIONS AND DETAILS
- 91 AT-S-23 AERATION TANKS - REPAIR PLAN, SECTIONS & DETAILS
- 92 FT-S-1 EXISTING FINAL SETTLING TANKS - BRACKET REPAIR
- 93 FT-S-2 FINAL SETTLING TANKS - PLANS, SECTIONS & DETAILS
- 94 FT-S-3 FINAL SETTLING TANKS - SECTIONS & DETAILS I
- 95 FT-S-4 FINAL SETTLING TANKS - SECTIONS & DETAILS II
- 96 FT-S-5 FINAL SETTLING TANKS DISTRIBUTION BOXES - PLANS
- 97 FT-S-6 FINAL SETTLING TANKS DISTRIBUTION BOXES - SECTIONS & DETAILS
- 98 PS-S-1 EXISTING SLUDGE RECIRCULATION PUMPING STATIONS - PLANS, SECTIONS & DETAILS
- 99 SP-S-1 EXISTING SLUDGE PROCESSING COMPLEX - PARTIAL BASEMENT PLAN & SECTIONS
- 100 MB-S-1 MAINTENANCE BUILDING - PLANS, SECTIONS & DETAILS
- 101 MB-S-2 MAINTENANCE BUILDING - PLAN, SECTIONS & DETAILS
- 102 MB-S-3 MAINTENANCE SUPPORT FACILITY - PLANS, SECTIONS & DETAILS
- 103 MB-S-4 MAINTENANCE SUPPORT FACILITY - SECTIONS & DETAILS
- 104 YS-S-1 MISCELLANEOUS YARD STRUCTURES - PLANS & SECTIONS
- 105 SD-S-1 STANDARD CONCRETE DETAILS I
- 106 SD-S-2 STANDARD CONCRETE DETAILS II
- 107 SD-S-3 STANDARD CONCRETE MODIFICATION DETAILS
- 108 SD-S-4 STANDARD MISCELLANEOUS DETAILS I
- 109 SD-S-5 STANDARD MISCELLANEOUS DETAILS II
- 110 SD-S-6 STANDARD CMU DETAILS
- 111 SD-S-7 CONCRETE BEAM AND COLUMN SCHEDULES AND DETAILS

MECHANICAL

- 112 GD-M-1 MECHANICAL SYMBOL LEGEND - ABBREVIATIONS AND GENERAL NOTES
- 113 PT-M-1 PRIMARY SETTLING TANK EFFLUENT CHANNEL PLAN AND SECTION
- 114 AT-M-1 EXISTING AERATION TANKS - DEMOLITION PLAN
- 115 AT-M-2 EXISTING AERATION TANKS - DEMOLITION SECTIONS
- 116 AT-M-3 AERATION TANKS NO. 1 & NO. 2 - LOWER PLAN
- 117 AT-M-4 AERATION TANKS NO. 3 & NO. 4 - LOWER PLAN
- 118 AT-M-5 AERATION TANKS NO. 1 & NO. 2 - TOP PLAN
- 119 AT-M-6 AERATION TANKS NO. 3 & NO. 4 - TOP PLAN
- 120 AT-M-7 AERATION TANK NO. 5 - TOP AND LOWER PLAN
- 121 AT-M-8 AERATION TANKS - SECTIONS I
- 122 AT-M-9 AERATION TANKS - SECTIONS II
- 123 AT-M-10 AERATION TANKS - SECTIONS III
- 124 AT-M-11 AERATION TANKS - PLANS, SECTIONS AND DETAILS I
- 125 AT-M-12 AERATION TANKS - PLANS, SECTIONS AND DETAILS II
- 126 AT-M-13 AERATION AND CHANNEL AIR BLOWERS - PLANS AND SECTIONS
- 127 AT-M-14 AERATION BLOWERS - SECTIONS AND DETAILS
- 128 AT-M-15 HYDRAULIC WASTING BOX AND CHANNEL AIR DIFFUSER SCHEDULE AND DETAILS
- 129 AT-M-16 DIFFUSER LAYOUT FOR AERATION TANK NO.1 - BOTTOM PLAN AND DETAILS
- 130 AT-M-17 DIFFUSER LAYOUT FOR AERATION TANK NO.4 - BOTTOM PLAN AND DETAILS

MECHANICAL CONTINUED

- 131 FT-M-1 EXISTING FINAL SETTLING TANKS 1,2,3 & 4 - DEMOLITION PLAN, SECTIONS & DETAILS
- 132 FT-M-2 NORTH AND SOUTH DISTRIBUTION BOXES - DEMOLITION - PLANS AND SECTIONS
- 133 FT-M-3 FINAL SETTLING TANKS - PLAN AND SECTIONS
- 134 FT-M-4 FINAL SETTLING TANKS - SECTIONS AND DETAILS
- 135 FT-M-5 FINAL SETTLING TANK DISTRIBUTION BOX - PLAN, SECTIONS & DETAILS
- 136 PS-M-1 SOUTH SLUDGE RECIRCULATION PUMP STATION - DEMOLITION - PLANS
- 137 PS-M-2 SOUTH SLUDGE RECIRCULATION PUMP STATION - DEMOLITION - PLANS AND SECTIONS
- 138 PS-M-3 NORTH SLUDGE RECIRCULATION PUMP STATION - DEMOLITION - PLANS
- 139 PS-M-4 NORTH SLUDGE RECIRCULATION PUMP STATION - DEMOLITION - PLANS AND SECTIONS
- 140 PS-M-5 SOUTH SLUDGE RECIRCULATION PUMP STATION - NEW WORK - PLANS I
- 141 PS-M-6 SOUTH SLUDGE RECIRCULATION PUMP STATION - NEW WORK - PLAN II AND SECTIONS
- 142 PS-M-7 SOUTH SLUDGE RECIRCULATION PUMP STATION - NEW WORK - SECTIONS
- 143 PS-M-8 NORTH SLUDGE RECIRCULATION PUMP STATION - NEW WORK - PLANS I
- 144 SP-M-1 SLUDGE PROCESSING COMPLEX - DEMOLITION - PLAN AND SECTIONS
- 145 SP-M-2 SLUDGE PROCESSING COMPLEX - NEW WORK - PLAN AND SECTIONS
- 146 SP-M-3 SLUDGE PROCESSING COMPLEX - NEW WORK AND DEMOLITION - PLAN AND SECTIONS
- 146ASP-M-4 SLUDGE PROCESSING COMPLEX - NEW WORK AND DEMOLITION - PLAN AND SECTIONS II
- 147 SD-M-1 MECHANICAL DETAILS I
- 148 SD-M-2 MECHANICAL DETAILS II
- 149 SD-M-3 MECHANICAL DETAILS III

HVAC

- 150 GD-H-1 HVAC LEGEND/SYMBOLS/ABBREVIATIONS
- 151 PS-H-1 SOUTH SLUDGE RECIRC PUMP STATION - DEMOLITION PLANS AND SECTIONS
- 152 PS-H-2 SOUTH SLUDGE RECIRCULATION PUMP STATION NEW WORK-PLANS AND SECTIONS
- 153 PS-H-3 NORTH SLUDGE RECIRC PUMP STATIONS - DEMOLITION PLANS AND SECTIONS
- 154 PS-H-4 NORTH SLUDGE RECIRCULATION PUMP STATIONS -NEW WORK PLANS AND SECTIONS
- 155 SP-H-1 SLUDGE PROCESSING BUILDING-BASEMENT PLAN-MODIFICATIONS
- 156 SP-H-2 SLUDGE PROCESSING BUILDING BLDG-FIRST FLOOR PLAN-DEMOLITION PLAN & MODIFICATION PLAN
- 157 MB-H-1 MAINTENANCE BUILDING DEMOLITION PLANS
- 158 MB-H-2 MAINTENANCE BUILDING LOWER AND UPPER LEVEL-NEW WORK
- 159 MB-H-3 MAINTENANCE SUPPORT FACILITY -FLOOR PLAN & SECTIONS
- 160 SD-H-1 HVAC STANDARD DETAILS I
- 161 SD-H-2 HVAC STANDARD DETAIL II
- 162 SD-H-3 BOILER PIPING DIAGRAMS
- 163 SD-H-4 ATC DIAGRAM 1
- 164 SD-H-5 ATC DIAGRAM II

PLUMBING


- 165 GD-P-1 PLUMBING-ABBREVIATIONS/SYMBOLS
- 166 PS-P-1 SLUDGE RECIRCULATION PUMP STATIONS - PLANS
- 167 SP-P-1 SLUDGE COMPLEX - BASEMENT PLAN
- 168 SP-P-2 SLUDGE COMPLEX - FIRST FLOOR - PART PLANS
- 169 MB-P-1 MAINTENANCE BUILDING - DEMOLITION PLANS
- 170 MB-P-2 MAINTENANCE BUILDING - NEW WORK PLANS
- 171 MB-P-3 MAINTENANCE SUPPORT FACILITY - PLANS
- 172 MB-P-4 MAINTENANCE SUPPORT FACILITY - RISER DIAGRAMS
- 173 SD-P-1 PLUMBING - TYPICAL DETAILS

RECORD DRAWING

File: GGNX001.DWG Plotted on: 8-May-12

11/09							
REV. NO.	DATE	DRWN	CHKD	REMARKS			
1/07	VJB	ZN		REVISED PER ADDENDA NOS. 1 THROUGH 4			

 CADD FILE NO. GGNX002
 DESIGNED BY: J. CROSS
 DRAWN BY: V. BITTO
 SHEET CHK'D BY: W. D. GREEN
 SCALE: NTS
 APPROVED BY: _____
 DATE: NOVEMBER 2006



CDM Camp Dresser & McKee Inc.
 consulting
 engineering
 construction
 operations

UPPER BLACKSTONE
 WATER POLLUTION ABATEMENT DISTRICT
 CONTRACT No. UB 3 - 0 - 17512 - 0023

**WASTEWATER TREATMENT FACILITY
 IMPROVEMENTS - PHASE II**

INDEX OF DRAWINGS I

PROJECT NO.
1289\45571

Sht. 2 of 276

GD-1

Accession No. 1289-68513

INDEX SHEET

INSTRUMENTATION

174	GD-I-1	LEGEND SHEET I
175	GD-I-2	LEGEND SHEET II
176	GD-I-3	CONTROL SYSTEM ARCHITECTURE
177	GD-I-4	VFD COMMUNICATION NETWORK LAYOUT
178	GD-I-5	INSTALLATION DETAILS
179	GD-I-6	DO ANALYZER/TRANSMITTER ARCHITECTURE & INSTALLATION DETAIL
180	GD-I-7	OMITTED
181	GD-I-8	VALVE COMMUNICATION NETWORK
182	P&ID-1	AERATION TANKS NOS. 1 AND 2 WASTEWATER FLOW
183	P&ID-2	AERATION TANKS NOS. 3 AND 4 WASTEWATER FLOW
184	P&ID-3	AERATION TANKS NOS. 1 AND 2 AIR DISTRIBUTION
185	P&ID-4	AERATION TANKS NOS. 3 AND 4 AIR DISTRIBUTION
186	P&ID-5	AERATION SYSTEM BLOWER NO. 1
187	P&ID-6	AERATION SYSTEM BLOWER NO. 2
188	P&ID-7	AERATION SYSTEM BLOWER NO. 3
189	P&ID-8	AERATION SYSTEM BLOWER NO. 4
190	P&ID-9	AERATION TANK EFFLUENT CHANNEL LOW PRESSURE AIR BLOWERS
191	P&ID-10	NORTH FINAL SETTLING TANKS
192	P&ID-11	SOUTH FINAL SETTLING TANKS
193	P&ID-12	NORTH RAS PUMPS
194	P&ID-13	SOUTH RAS PUMPS
195	P&ID-14	NORTH WAS PUMPS
196	P&ID-15	SOUTH WAS PUMPS
197	P&ID-16	NORTH SLUDGE RECIRCULATION PUMP STATION TANK DRAIN AND SCUM SYSTEM
198	P&ID-17	SOUTH SLUDGE RECIRCULATION PUMP STATION TANK DRAIN AND SCUM SYSTEM
199	P&ID-18	SODIUM HYDROXIDE TANKS
200	P&ID-19	SODIUM HYDROXIDE PUMPS
201	P&ID-20	DAF & AERATION TANKS POLYMER PUMPS
202	P&ID-21	AERATION TANK NO.5 WASTEWATER FLOW
203	P&ID-22	AERATION TANK NO.5 AIR DISTRIBUTION
204	P&ID-23	MISCELLANEOUS I
205	P&ID-24	MISCELLANEOUS II
206	P&ID-25	WET WEATHER DISCHARGE

ELECTRICAL

207	GD-E-1	ELECTRICAL SYMBOLS AND ABBREVIATIONS I
208	GD-E-2	ELECTRICAL SYMBOLS AND ABBREVIATIONS II
209	GD-E-3	ELECTRICAL AREA CLASSIFICATION SITE PLAN
210	GD-E-4	ELECTRICAL AREA CLASSIFICATION PLANS AND SECTIONS
211	GD-E-5	OVERALL ELECTRICAL SITE DEMOLITION PLAN
212	GD-E-6	ELECTRICAL SITE PLAN I
213	GD-E-7	ELECTRICAL SITE PLAN II
214	GD-E-8	ELECTRICAL SITE LIGHTING PLAN I
215	GD-E-9	ELECTRICAL SITE LIGHTING PLAN II
216	GD-E-10	DUCTBANK SECTIONS I
217	GD-E-11	DUCTBANK SECTIONS II
218	GD-E-12	ELECTRICAL OVERALL EXISTING ONE LINE DIAGRAM
219	GD-E-13	ELECTRICAL OVERALL NEW WORK ONE LINE DIAGRAM
220	GD-E-14	ELECTRICAL SUBSTATION NO. 2 ONE LINE DIAGRAM DIAGRAMS
221	GD-E-15	ELECTRICAL SUBSTATION NO. 4 ONE LINE DIAGRAM DIAGRAMS
222	GD-E-16	ELECTRICAL SUBSTATION NO. 5 AND 5KV MOTOR CONTROL CENTER ONE LINE DIAGRAM
223	GD-E-17	MCC-3B & 3C ONE LINE DIAGRAM
224	GD-E-18	MCC-3A, 3D & 3E ONE LINE DIAGRAM
225	GD-E-19	MCC-7 ONE LINE DIAGRAM
226	GD-E-20	MCC-8 ONE LINE DIAGRAM
227	GD-E-21	MCC-17 & 18 ONE LINE DIAGRAMS
228	GD-E-22	ELECTRICAL GROUNDING DETAILS
229	GD-E-23	ELECTRICAL GROUNDING PLANS & SCHEMATICS
230	GD-E-24	PANELBOARD SCHEDULES I
231	GD-E-25	PANELBOARD SCHEDULES II
232	GD-E-26	PANELBOARD SCHEDULES III
233	GD-E-27	FIRE ALARM & GAS DETECTION RISER DIAGRAMS
234	GD-E-28	PAGE/PARTY & CARD ACCESS RISER DIAGRAMS
235	GD-E-29	INSTRUMENTATION SYSTEM ARCHITECTURE & DATA HIGHWAY DIAGRAMS
236	GD-E-30	INSTRUMENTATION SYSTEM BLOCK DIAGRAMS
237	GD-E-31	POWER MONITORING SYSTEM & PROCESS EQUIPMENT NETWORK DIAGRAMS
238	GD-E-32	CONTROL SCHEMATICS I
239	GD-E-33	CONTROL SCHEMATICS II
240	GD-E-34	CONTROL SCHEMATICS III
241	GD-E-35	CONTROL SCHEMATICS IV
242	GD-E-36	UNDERGROUND RACEWAY SCHEDULE I
243	GD-E-37	UNDERGROUND RACEWAY SCHEDULE II

ELECTRICAL CONTINUED

244	AT-E-1	EXISTING AERATION TANKS - DEMOLITION PLAN
245	AT-E-2	EXISTING AERATION TANKS - AERATOR CONTROL BUILDING DEMOLITION PLANS
246	AT-E-3	AERATION TANKS NO.1 & 2 - ELECTRICAL PLAN
247	AT-E-4	AERATION TANKS NO.3 & 4 - ELECTRICAL PLANS
248	AT-E-5	AERATION TANK NO.5 - ELECTRICAL PLAN
249	AT-E-6	BLOWER AREA - ENLARGED PLANS I
250	AT-E-7	BLOWER AREA - ENLARGED PLANS II
251	AT-E-8	BLOWER AREA - LIGHTING AND SYSTEMS PLAN
252	AT-E-9	BLOWER AREA GROUNDING PLAN
253	AT-E-10	AERATION TANKS - MISCELLANEOUS PLANS, SECTIONS AND DETAILS
254	FT-E-1	EXISTING FINAL SETTLING TANKS - DEMOLITION PLAN
255	FT-E-2	NEW FINAL SETTLING TANKS - PLANS AND SECTIONS
256	PS-E-1	NORTH & SOUTH - SLUDGE RECIRCULATION PUMP STATIONS - DEMOLITION PLANS
257	PS-E-2	SOUTH SLUDGE RECIRCULATION PUMP STATION - ELECTRICAL POWER PLANS I
258	PS-E-3	SOUTH SLUDGE RECIRCULATION PUMP STATION - ELECTRICAL POWER PLANS II
259	PS-E-4	SOUTH SLUDGE RECIRC. PUMP STATION - LIGHTING & SYSTEMS PLANS
260	PS-E-5	NORTH SLUDGE RECIRCULATION PUMP STATION - ELECTRICAL POWER PLANS I
261	PS-E-6	NORTH SLUDGE RECIRCULATION PUMP STATION - ELECTRICAL POWER PLANS II
262	PS-E-7	NORTH SLUDGE RECIRC. PUMP STATION - ELECTRICAL LIGHTING & SYSTEMS PLANS
263	SP-E-1	SLUDGE PROCESSING COMPLEX - FILTER AREA DEMOLITION PLANS
264	SP-E-2	SLUDGE PROCESSING COMPLEX - FILTER AREA BASEMENT NEW WORK PLAN
265	SP-E-3	SLUDGE PROCESSING COMPLEX - FILTER AREA FIRST FLOOR NEW WORK PLAN
266	MB-E-1	MAINTENANCE BUILDING DEMOLITION PLANS
267	MB-E-2	MAINTENANCE BUILDING - ONE LINE DIAGRAM & PANEL SCHEDULES
268	MB-E-3	MAINTENANCE BUILDING LOWER LEVEL - ELECTRICAL POWER PLAN
269	MB-E-4	MAINTENANCE BUILDING UPPER LEVEL - ELECTRICAL POWER PLAN
270	MB-E-5	MAINTENANCE BUILDING LOWER & UPPER LEVELS - ELECTRICAL LIGHTING & SYSTEMS PLANS
271	MB-E-6	MAINTENANCE SUPPORT FACILITY - ELECTRICAL POWER PLAN
272	MB-E-7	MAINTENANCE SUPPORT FACILITY - ELECTRICAL LIGHTING & SYSTEMS PLANS
273	SD-E-1	ELECTRICAL LIGHTING FIXTURE SCHEDULE I
274	SD-E-2	STANDARD ELECTRICAL DETAILS I
275	SD-E-3	STANDARD ELECTRICAL DETAILS II
276	SD-E-4	STANDARD ELECTRICAL DETAILS III

RECORD DRAWING

11/09					
1/07	VJB	ZN		REVISED PER ADDENDA NOS. 1 THROUGH 4	
REV. NO.	DATE	DRWN	CHKD	REMARKS	

CADD FILE NO. <u>GPNX002</u>
DESIGNED BY: <u>J. CROSS</u>
DRAWN BY: <u>V. BITTO</u>
SHEET CHK'D BY: <u>W. D. GREEN</u>
SCALE: <u>NTS</u>
APPROVED BY: <u> </u>
DATE: <u>NOVEMBER 2006</u>

CDM Camp Dresser & McKee Inc.
consulting
engineering
construction
operations

UPPER BLACKSTONE
WATER POLLUTION ABATEMENT DISTRICT
CONTRACT No. UB 3 - 0 - 17512 - 0023



**WASTEWATER TREATMENT FACILITY
IMPROVEMENTS - PHASE II**

INDEX OF DRAWINGS II

PROJECT NO.
1289\45571

Sht. 3 of 276

GD-2

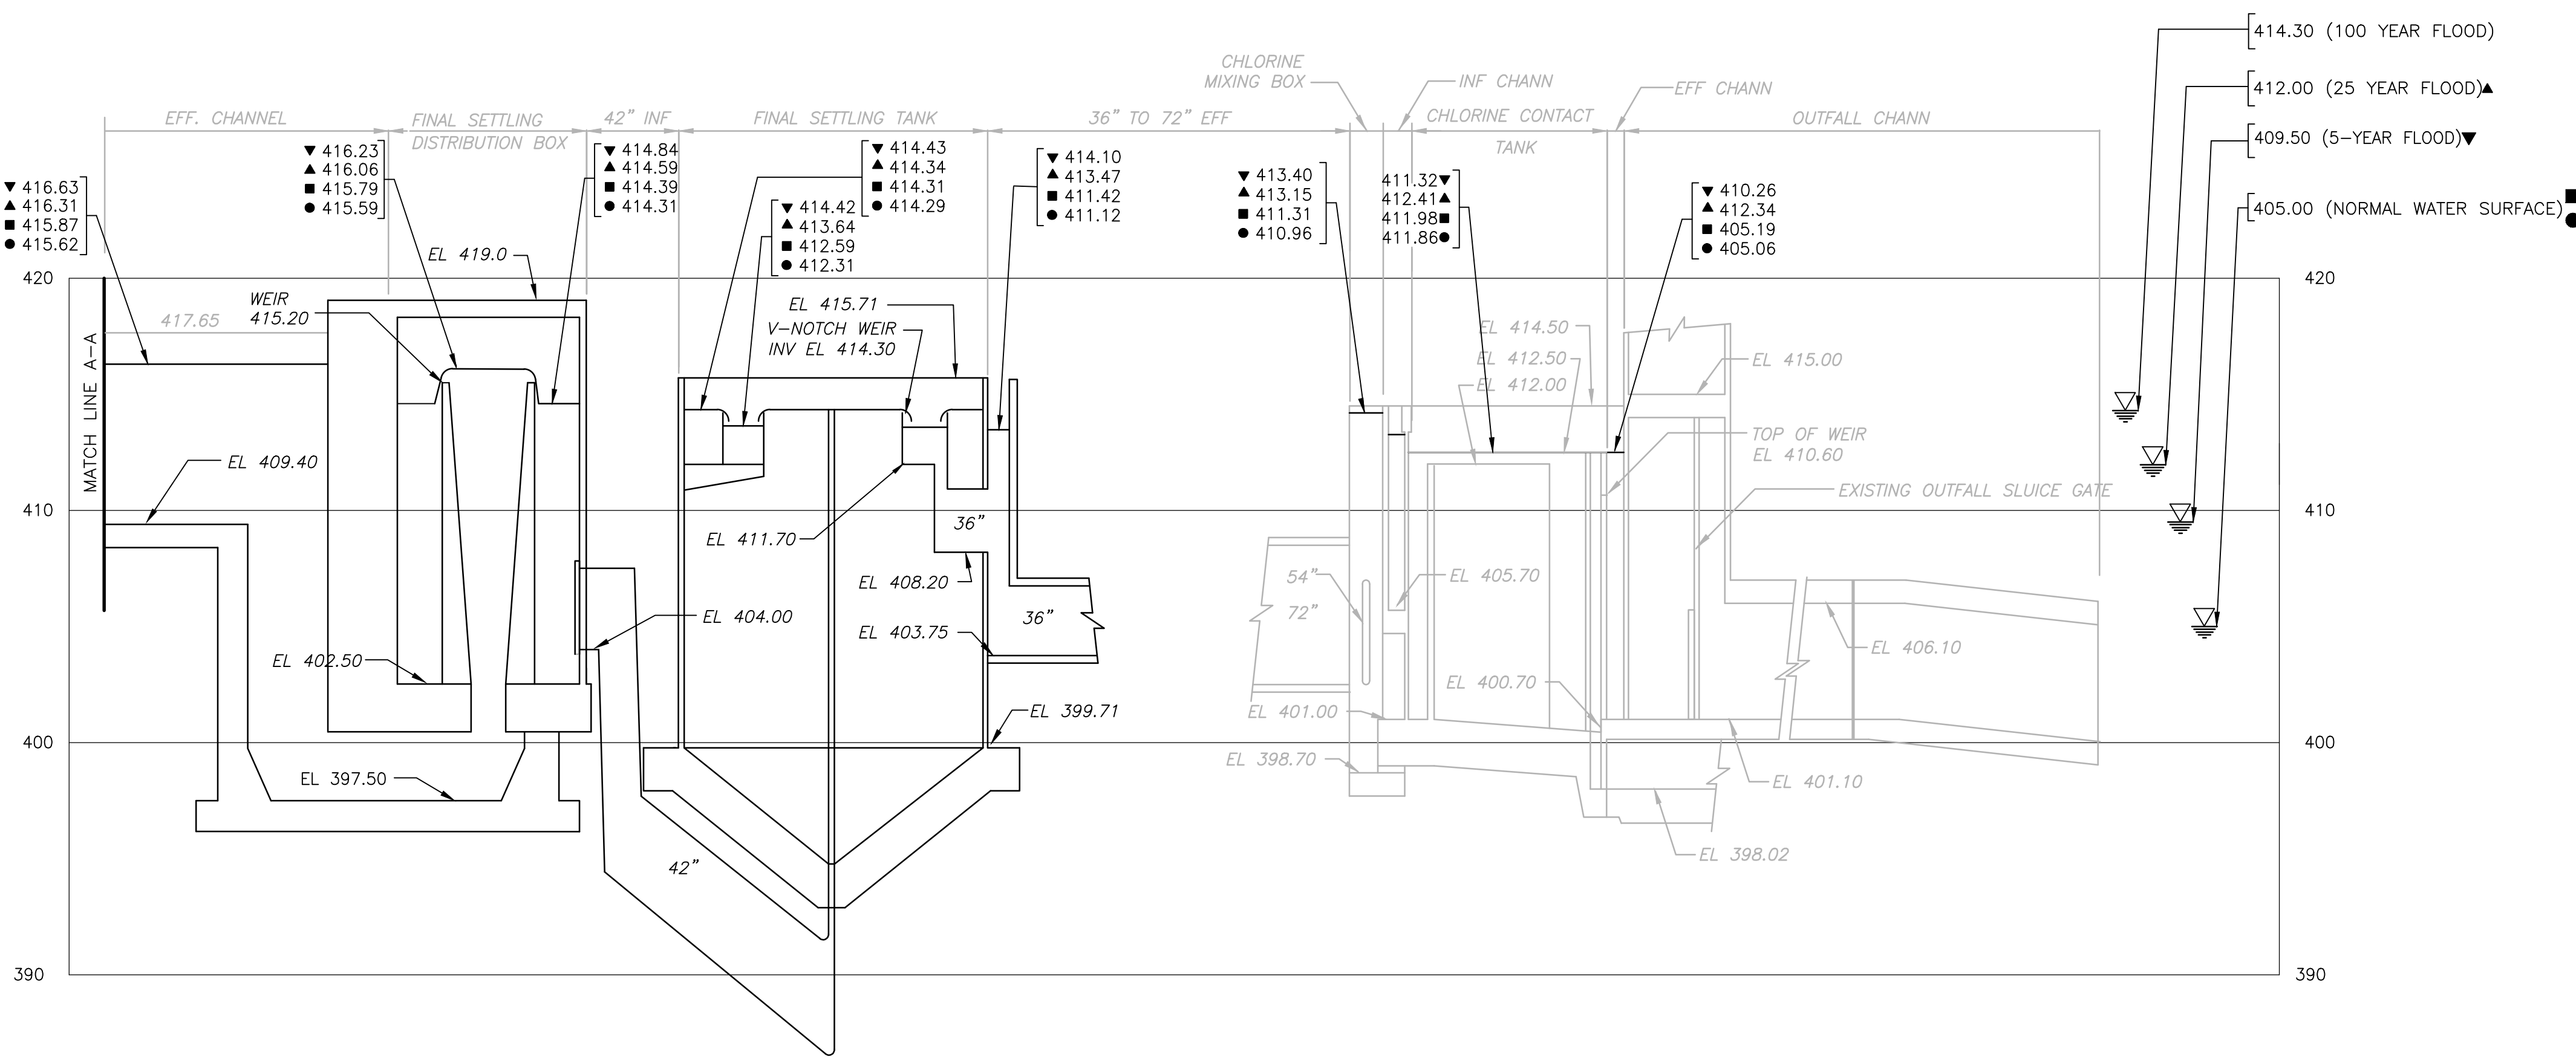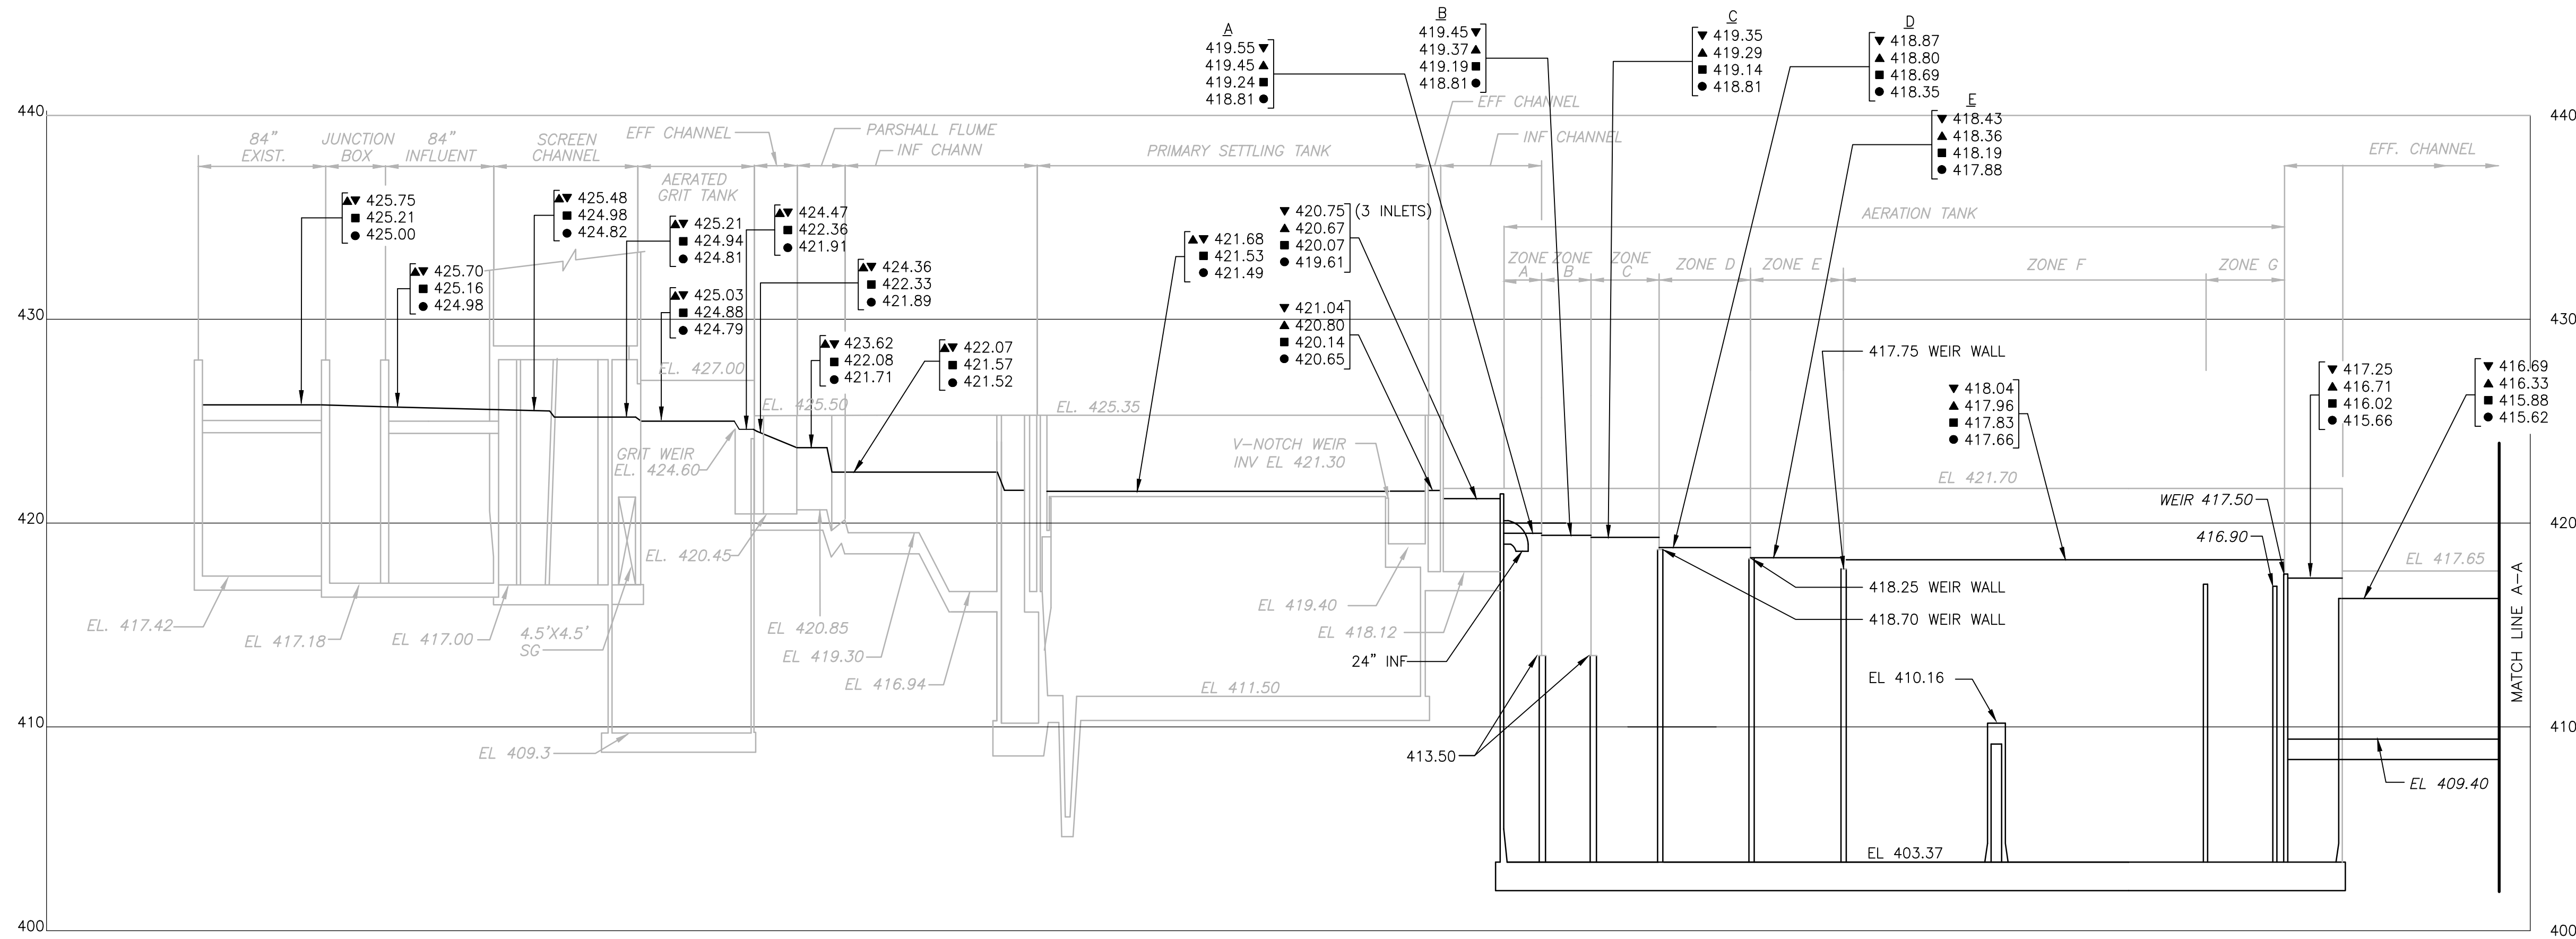

NOTES:
HYDRAULIC GRADE LINE SHOWN FOR PEAK HOURLY PLANT FLOW (MAXIMUM DAY 80 MGD TO ADVANCED TREATMENT) WITH RIVER AT 412.0'. (25-YR FLOOD) ▲

THE VERTICAL DATUM IS REFERENCED TO THE NATIONAL GEODETIC VERTICAL DATUM OF 1929 (NGVD29)

- COMPLETION OF PHASE II**
- ▲ ESTIMATED WATER SURFACE ELEVATION AT 160 MGD PEAK HOURLY PLANT FLOW (120 MGD TO ADVANCED TREATMENT INCLUDES SIDESTREAMS) AND MODERATELY HIGH RIVER (5-YEAR FLOOD)
57 MGD RAS
150 MGD INTERNAL RECYCLE
OPERATING UNITS:
4 SCREENS,
4 AERATED GRIT TANKS,
7 PRIMARY SETTLING TANKS,
4 AERATION TANKS,
8 FINAL SETTLING TANKS, AND
2 CHLORINE CONTACT TANKS.
 - ▲ ESTIMATED WATER SURFACE ELEVATION AT 160 MGD PEAK HOURLY PLANT FLOW, (MAXIMUM DAY 80 MGD TO ADVANCED TREATMENT INCLUDES SIDESTREAMS) AND PEAK, 25-YEAR RIVER FLOOD,
57 MGD RAS
150 MGD INTERNAL RECYCLE.
OPERATING UNITS:
4 SCREENS,
4 AERATED GRIT TANKS,
7 PRIMARY SETTLING TANKS,
4 AERATION TANKS,
8 FINAL SETTLING TANKS, AND
2 CHLORINE CONTACT TANKS.
 - ESTIMATED WATER SURFACE ELEVATION AT AVERAGE DAILY FLOW
45 MGD PLANT FLOW (46.6 MGD TO ADVANCED TREATMENT INCLUDES SIDESTREAMS)
31 MGD RAS
150 MGD INTERNAL RECYCLE.
OPERATING UNITS:
2 SCREENS,
2 AERATED GRIT TANKS,
6 PRIMARY SETTLING TANKS,
4 AERATION TANKS,
8 FINAL SETTLING TANKS, AND
2 CHLORINE CONTACT TANKS.
 - ESTIMATED WATER SURFACE ELEVATION AT MINIMUM DAILY FLOW
24 MGD PLANT FLOW (25.6 MGD TO ADVANCED TREATMENT INCLUDES SIDESTREAMS)
16.6 MGD RAS
0 MGD INTERNAL RECYCLE
OPERATING UNITS:
2 SCREENS,
2 AERATED GRIT TANKS,
5 PRIMARY SETTLING TANKS,
4 AERATION TANKS,
8 FINAL SETTLING TANKS, AND
2 CHLORINE CONTACT TANKS.

SCALE
1"=5'0" VERTICAL

RECORD DRAWING

File: MHYPRO01.DWG Plotted on: 18-May-12

REV. NO.	DATE	DRWN	CHKD	REMARKS
11/09				

CADD FILE NO. MHYPRO01.DWG
DESIGNED BY: R. LARAMIE
DRAWN BY: V. BITTO
SHEET CHK'D BY: R. LARAMIE
SCALE: NONE
APPROVED BY: W.D. GREEN
DATE: NOVEMBER 2008



CDM Camp Dresser & McKee Inc.
consulting
engineering
construction
operations

**UPPER BLACKSTONE
WATER POLLUTION ABATEMENT DISTRICT
CONTRACT No. UB 3 - 0 - 17512 - 0023**

**WASTEWATER TREATMENT FACILITY
IMPROVEMENTS - PHASE II**

**HYDRAULIC PROFILE
AT COMPLETION OF PHASE II**

PROJECT NO.
1289\45571
Sht. 5 of 276
GD-4
ACCESSION NO. 1289-68616

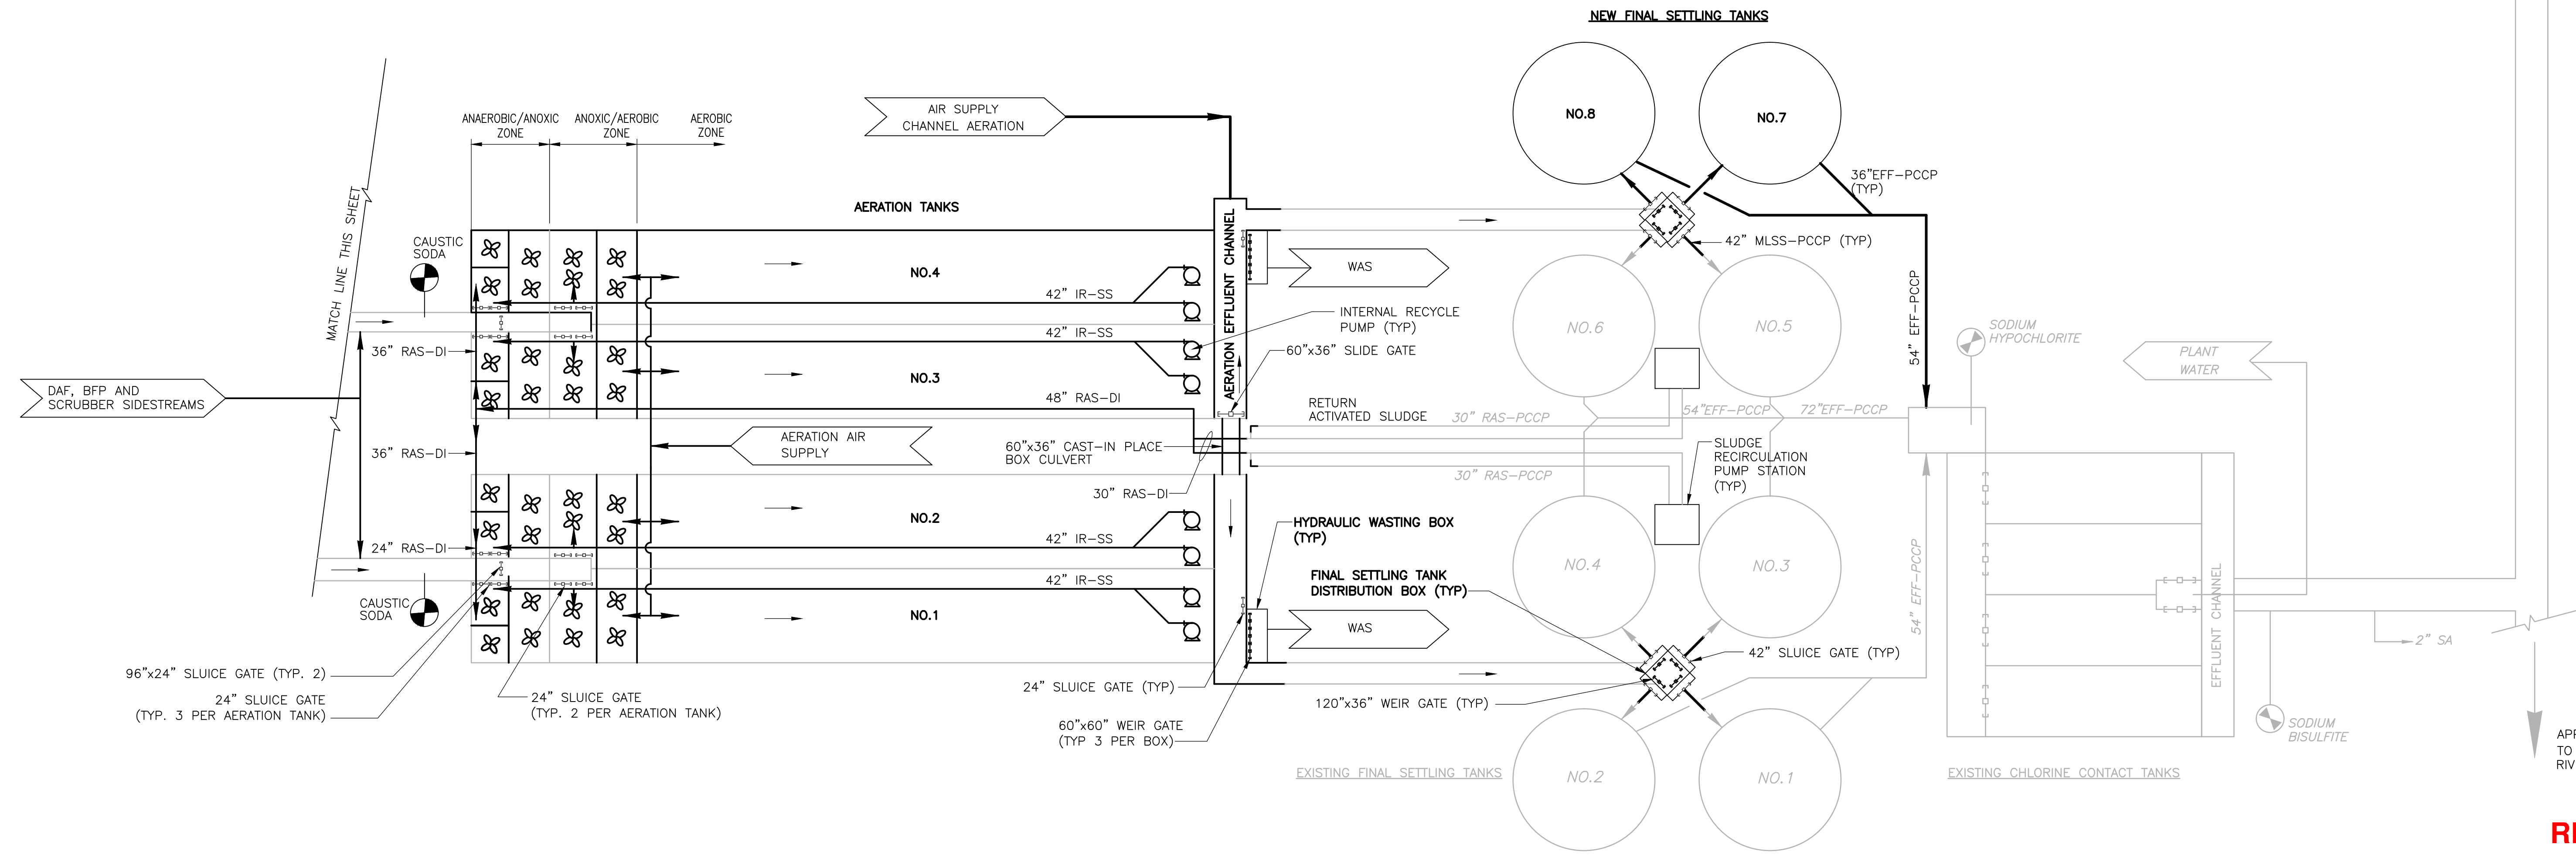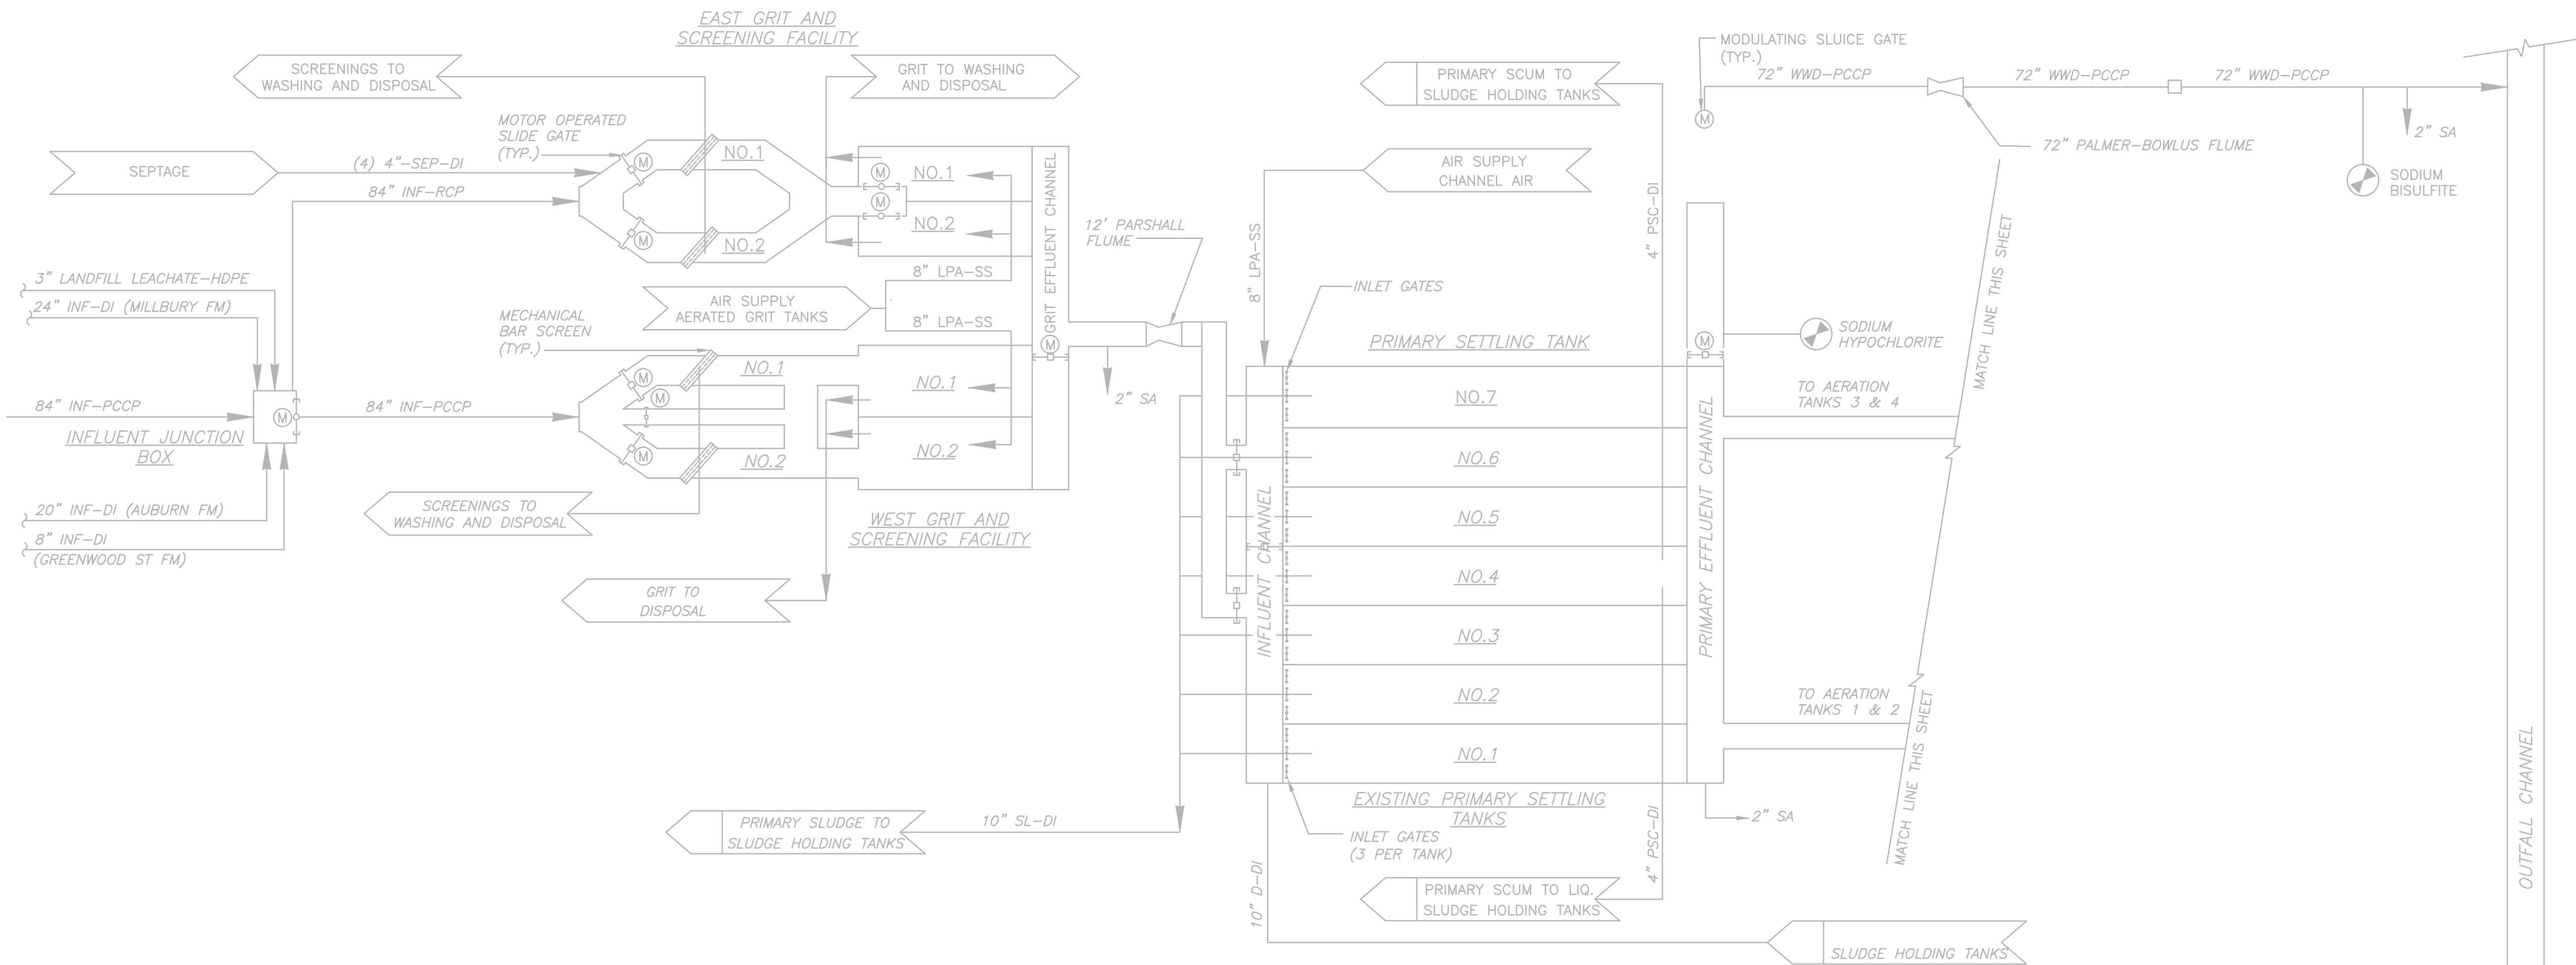

NOTE:
 1. REFER TO SECTION 00300 AND SECTION 01025 FOR DESCRIPTION OF ADD ALTERNATE NO. 2 SCOPE OF WORK.

LEGEND:
 [Symbol] NEW
 [Symbol] EXISTING
 APPROX. 2000 FT. TO BLACKSTONE RIVER

RECORD DRAWING

File: MPRFD001.DWG Plotted on: 18-May-12

11/09				REVISED FOR RECORD
CADD FILE NO. MPRFD001.DWG		DESIGNED BY: M. NEVILLE		
DRAWN BY: V. BITTO		SHEET CHK'D BY: W. D. GREEN		
SCALE: NONE		APPROVED BY:		
DATE: NOVEMBER 2006		REMARKS		

CDM Camp Dresser & McKee Inc.
 consulting engineering construction operations

UPPER BLACKSTONE
 WATER POLLUTION ABATEMENT DISTRICT
 CONTRACT No. UB 3 - 0 - 17512 - 0023
**WASTEWATER TREATMENT FACILITY
 IMPROVEMENTS - PHASE II**

**LIQUID PROCESS FLOW DIAGRAM
 PHASE II**

PROJECT NO. 1289\45571
 Sht. 6 of 276
GD-5
 ACROSSON NO. 1289-69617